

PARTS LIST


ITEM NO	COMPONENT	PART NO.	DESCRIPTION	MANUFACTURER	QTY	REMARKS
1	FOUNTAIN	-	30" DIA BALL - GFRC	TREVI	1	COLOR OPTIONAL
2		-	48" O.D. WOK ROUND BASE GFRC	TREVI	1	COLOR OPTIONAL
3	TUBING	-	3/4" DIA PVC COUPLER SOCKET END	-	1	PRE-INSTALLED
4		-	3/4"x1/2" DIA PVC CONCENTRIC REDUCER SOCKET END	-	1	PRE-INSTALLED
5		-	1/2" DIA x 10"LG PVC PIPE PLAIN END	-	1	PRE-INSTALLED
6	PARTS BAG	A100	1/2" DIA BALL VALVE PVC SCH. 40 150 PSI	-	1	
7		A100	5/8" I.D. x 10"LG TUBING - CLEAR VINYL PLAIN END	-	1	
8		A100	SHIM PLASTIC	EZ - SHIM	4	
9		A100	1-1/4" RUBBER PLUG	TREVI	1	
10	PUMP	-	1/2" I.D. x 2" L HOSE TAIL - CLEAR VINYL PLAIN END	JEAN TECH INC.	1	
11		-	1"x1/2" DIA ADAPTER THREADED	JEAN TECH INC.	1	
12		-	VA2600, 700 GPH SUBMERSIBLE PUMP	JEAN TECH INC.	1	

NOTE:

Electrical supply must conform with local & national regulation/codes. If in doubt consult an electrician.


To ease connections hot water may be used to soften PVC tubing. Pump and plumbing details may vary.

Precautions should be taken to prevent damage from water freezing in reservoir.

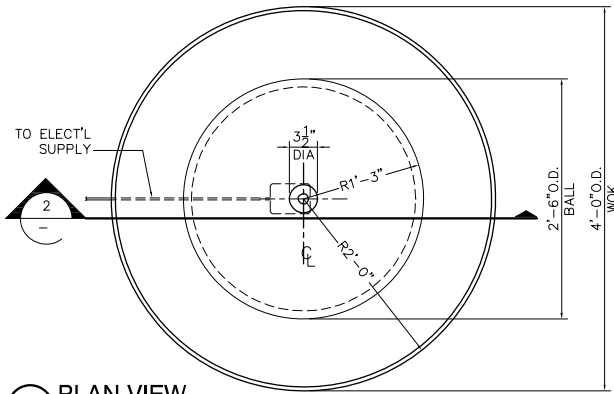




1 PLAN VIEW

SCALE: 1/2"=1'

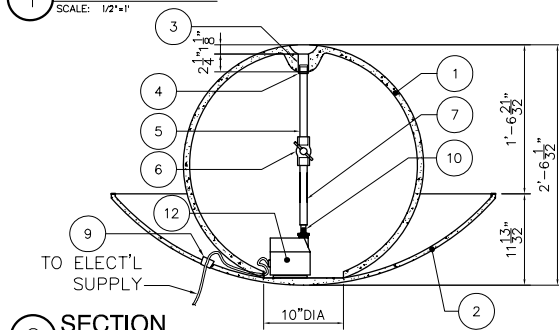

2 SECTION

SCALE: 1/2"=1'

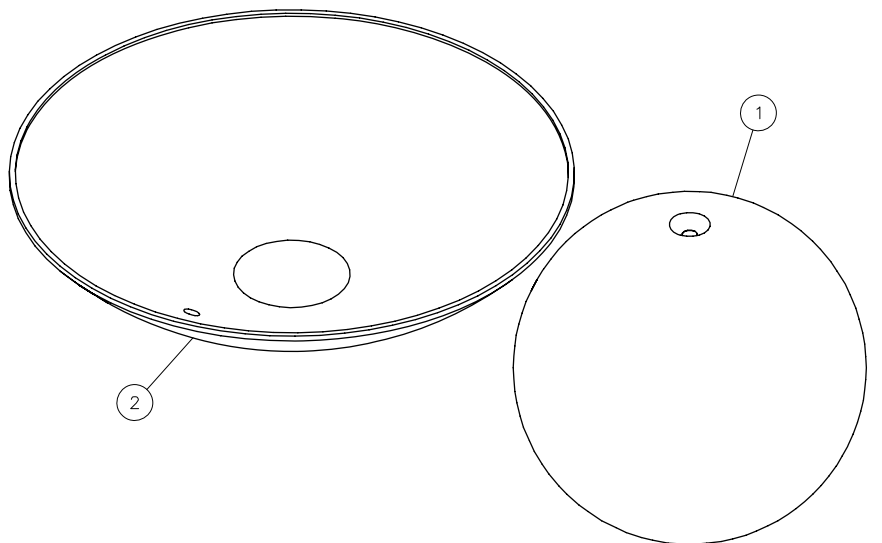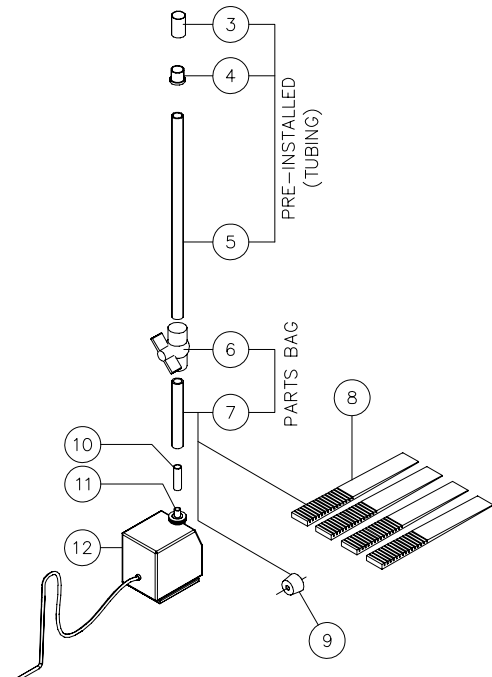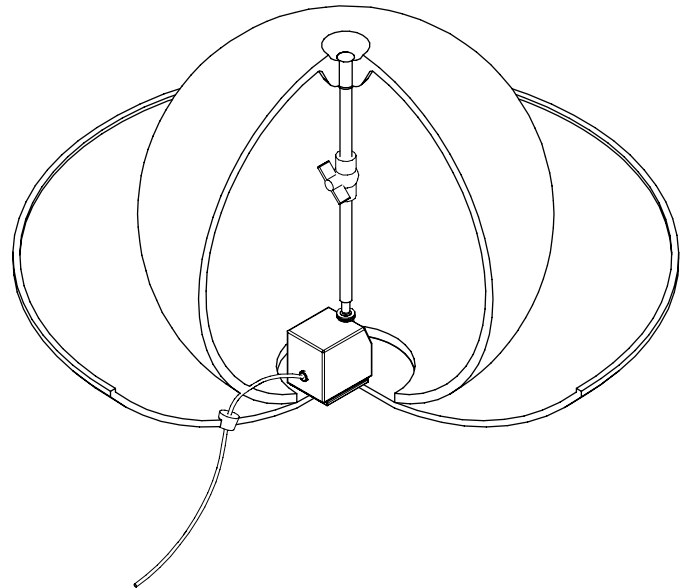

995 Governor Dr. #103
El Dorado Hills, CA 95762
866 382-8600

info@yardart.com

REVISIONS

DATE

BY

CONTENT

48F WLKP
BALL AND BOWL FOUNTAIN

DRAWING NO

48F WLKP
SHOP

BALL VALVE TO REPLACE COUPLER 8-15-06

PROJECT

48F WLKP

SHEET. NO. 1 OF 1