

PARTS LIST


ITEM NO	COMPONENT	PART NO.	DESCRIPTION	MANUFACTURER	QTY	REMARKS
①	FOUNTAIN	—	31"H x 18"W LARGE BUDDA FOUNTAIN — GFRC	TREVI	1	COLOR OPTIONAL
②		—	6"H x 28"W x 74"L BASE — GFRC	TREVI	1	COLOR OPTIONAL
③		—	4"H x 17-½"W x 17"L PEDESTAL — GFRC	TREVI	1	PRE-INSTALLED
④	TUBING	—	¾" DIA PVC COUPLER SOCKET END	—	1	PRE-INSTALLED
⑤		—	¾"x½" DIA PVC CONCENTRIC REDUCER SOCKET END	—	1	PRE-INSTALLED
⑥		—	1/2" DIA x 24" LG PVC PIPE PLAIN END	—	1	PRE-INSTALLED
⑦	PARTS BAG	A100	1/2" DIA BALL VALVE PVC SCH. 40 150 PSI	—	1	
⑧		A100	5/8" I.D. x 6"LG TUBING — CLEAR VINYL PLAIN END	—	1	
⑨		A100	SHIM PLASTIC	EZ — SHIM	4	
⑩		A100	1-¼" DIA RUBBER PLUG	—	1	
⑪	PUMP	—	½" I.D. x 2" L HOSE TAIL — CLEAR VINYL PLAIN END	JEAN TECH INC.	1	
⑫		—	1"x½" DIA ADAPTER THREADED	JEAN TECH INC.	1	
⑬		—	MODEL 1.9, PT505, 225 GPH SUBMERSIBLE PUMP	JEAN TECH INC.	1	

NOTE:


Electrical supply must conform with local & national regulation/codes.
If in doubt consult an electrician.

To ease connections hot water may be used to soften PVC tubing.
Pump and plumbing details may vary.


Precautions should be taken to prevent damage from water freezing in reservoir.

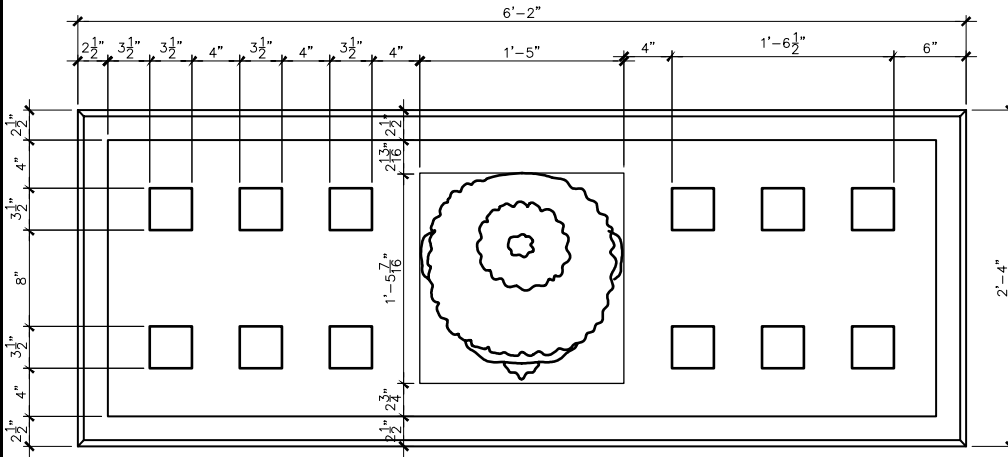

1 PLAN VIEW
SCALE: 3/4"=1'-0"

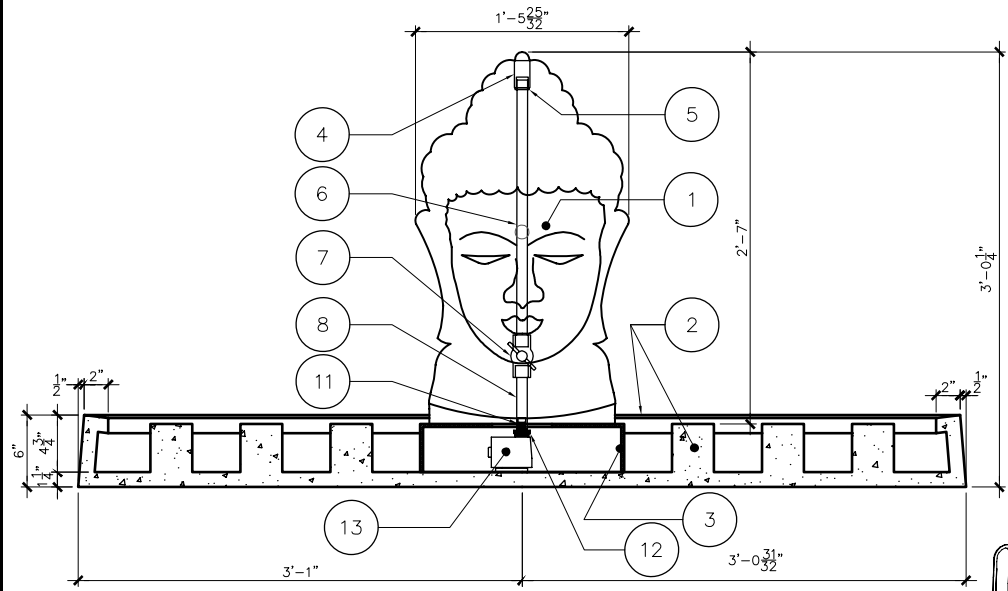

2 ELEVATION
SCALE: 3/4"=1'-0"

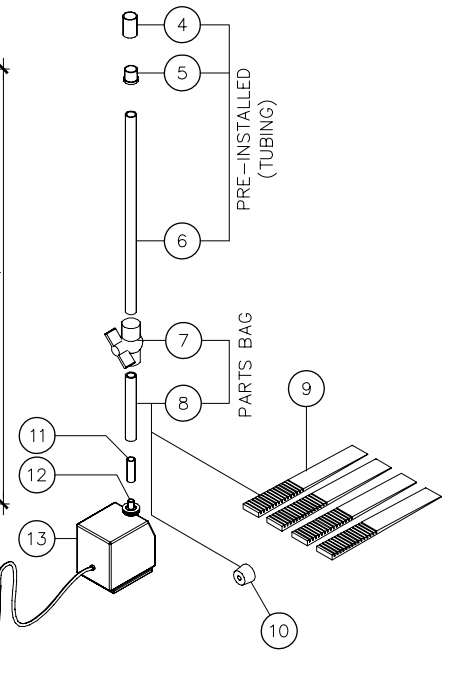

BHEAD-FTN-LARGE-SHOP.DWG



995 Governor Dr. #103
El Dorado Hills, CA 95762
866 382-8600

YARDART info@yardart.com

CONTENT
BHEAD-FTN-LARGE
BUDDA HEAD FOUNTAUN

PROJECT BHEAD-FTN-LARGE

DRAWING NO
BHEAD-FTN-LARGE
SHOP

SHEET. NO. 1 OF 1