

# PARTS LIST


| ITEM NO | COMPONENT | PART NO. | DESCRIPTION                                                                                  | MANUFACTURER        | QTY | REMARKS        |
|---------|-----------|----------|----------------------------------------------------------------------------------------------|---------------------|-----|----------------|
| ①       | FOUNTAIN  | —        | 24- $\frac{1}{4}$ "W x 24- $\frac{1}{4}$ "L x 18"D OBLIQUE FTN. (SMALL) GFRC                 | TREVI               | 1   | COLOR OPTIONAL |
| ②       |           | —        | 26- $\frac{1}{2}$ "W x 26- $\frac{1}{2}$ "L x 35- $\frac{1}{2}$ "D OBLIQUE FTN. (LARGE) GFRC | TREVI               | 1   | COLOR OPTIONAL |
| ③       |           | —        | 42-1/2"W x 42-1/2"L x 18-1/2"D SQUARE BASE — GFRC                                            | TREVI               | 1   | COLOR OPTIONAL |
| ④       |           | —        | 39-1/4"W x 39-1/4"L x 6- $\frac{3}{32}$ "D SQUARE BASEN — PLASTIC                            | TREVI               | 1   | BLACK          |
| ⑤       | TUBING    | —        | 3/4" DIA PVC COUPLER SOCKET END                                                              | —                   | 1   | PRE-INSTALLED  |
| ⑥       |           | —        | 1/2" x $\frac{3}{4}$ " DIA PVC CONCENTRIC REDUCER SOCKET END                                 | —                   | 2   | PRE-INSTALLED  |
| ⑦       |           | —        | 1" DIA x 10"LG PVC PIPE PLAIN END                                                            | —                   | 1   | PRE-INSTALLED  |
| ⑧       |           | —        | 1" DIA PVC COUPLER SOCKET END                                                                | —                   | 1   | PRE-INSTALLED  |
| ⑨       |           | —        | 1" DIA x 10-3/4"LG PVC PIPE PLAIN END                                                        | —                   | 1   | PRE-INSTALLED  |
| ⑩       |           | —        | 3/4" DIA x 3" LG CONNECTOR PVC PIPE PLAIN END                                                | —                   | 1   | PRE-INSTALLED  |
| ⑪       |           | —        | 1" DIA NON-RETURN VALVE PVC SCH. 40 200 PSI (CHECK VALVE)                                    | —                   | 1   | PRE-INSTALLED  |
| ⑫       |           | —        | 3/4" DIA BALL VALVE PVC SCH. 40 150 PSI                                                      | —                   | 1   | PRE-INSTALLED  |
| ⑬       | PARTS BAG | A106     | 7/8" I.D. x 6"L HOSE TAIL — CLEAR VINYL PLAIN END                                            | —                   | 1   |                |
| ⑭       |           | A106     | 5/8" I.D. x 6"L HOSE TAIL — CLEAR VINYL PLAIN END                                            | —                   | 1   |                |
| ⑮       |           | A106     | SHIM PLASTIC                                                                                 | EZ — SHIM           | 4   |                |
| ⑯       | PUMP      | —        | $\frac{1}{2}$ " DIA THREADED, SLIP ON DISCHARGE ADAPTER WITH VENTURI                         | COMMODITY AXIS INC. | 1   |                |
| ⑰       |           | —        | $\frac{1}{2}$ " DIA THREADED DISCHARGE ADAPTER                                               | COMMODITY AXIS INC. | 1   |                |
| ⑱       |           | —        | VA4900, 1200 GPH SUBMERSIBLE PUMP                                                            | COMMODITY AXIS INC. | 1   |                |

## NOTE:

Electrical supply must conform with local & national regulation/codes.  
If in doubt consult an electrician.

To ease connections hot water may be used to soften PVC tubing.  
Pump and plumbing details may vary.

Precautions should be taken to prevent damage from water freezing in reservoir.

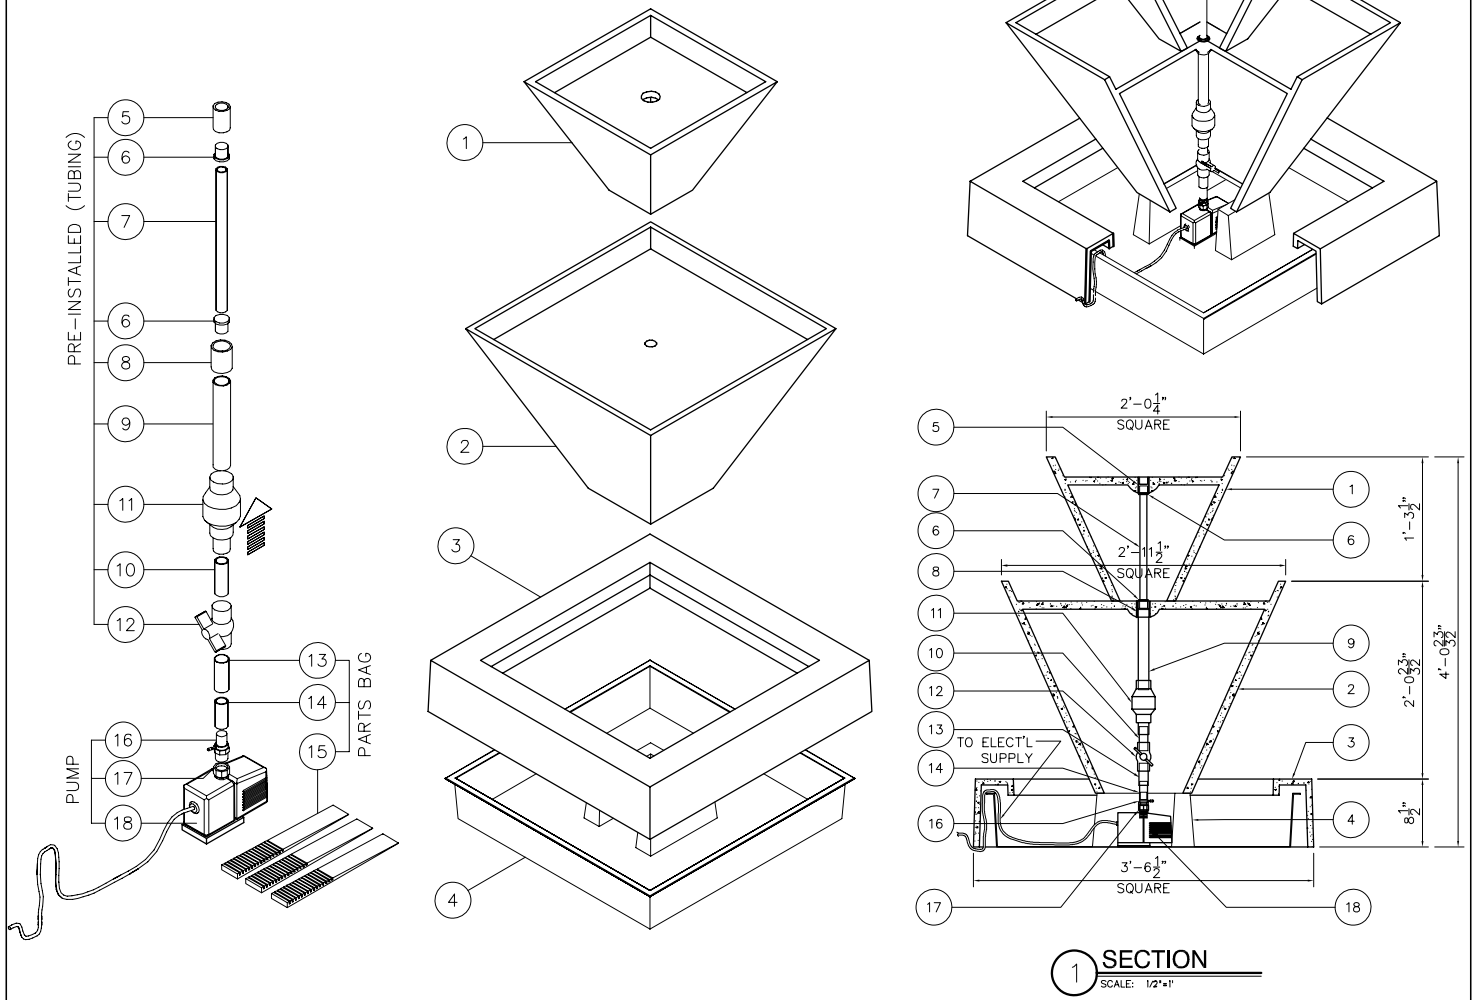

OBDF - SHOP.DWG



995 Governor Dr. #103  
El Dorado Hills, CA 95762  
866 382-8600

YARDART info@yardart.com

CONTENT  
OBDF  
DOUBLE OBLIQUE FOUNTAIN

DRAWING NO  
OBDF  
SHOP

PROJECT OBDF

SHEET. NO. 1 OF 1