


PARTS LIST


ITEM NO	COMPONENT	PART NO.	DESCRIPTION	MANUFACTURER	QTY	REMARKS
1	FOUNTAIN	-	38-1/2" H x 11"W x 11"L I FOUNTAIN - GFRC	GIST	1	COLOR OPTIONAL
2		-	30"W x 30"L x 8-1/4"D BASE - GFRC	GIST	1	COLOR OPTIONAL
3	TUBING	-	3/4" DIA PVC COUPLER SOCKET END	GIST	1	PRE-INSTALLED
4		-	1/2" DIA x 2' LG PVC PIPE PLAIN END	GIST	1	PRE-INSTALLED
5		-	3/4"x1/2" DIA PVC CONCENTRIC REDUCER SOCKET END	-	1	PRE-INSTALLED
6	PARTS BAG	A100	5/8" X 10" VINYL TUBE	-	1	
7		A100	1/2" DIA PVC BALL VALVE	-	1	
8		A100	SHIM PLASTIC	EZ - SHIM	4	
9		A100	1-1/4" RUBBER PLUG	-	1	
10	PUMP	-	MODEL 1.9 - PT505, 225 GPH SUBMERSIBLE PUMP	JEBAO	1	
11						

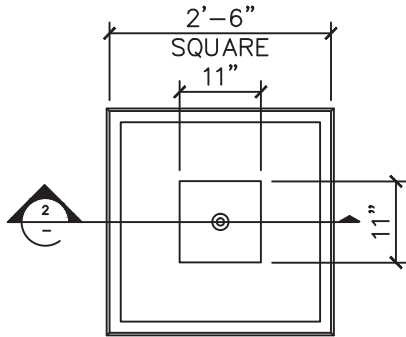


1 PLAN VIEW
SCALE: 1/2"=1'




3 ASSEMBLY
SCALE: N.T.S.

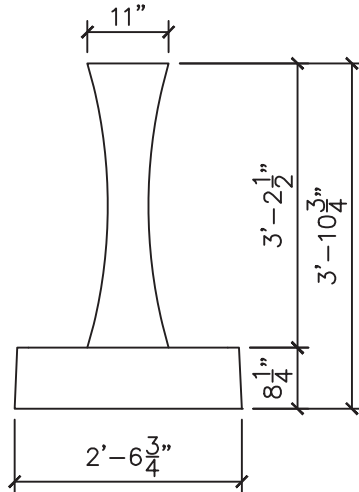

2 ELEVATION
SCALE: 1/2"=1'

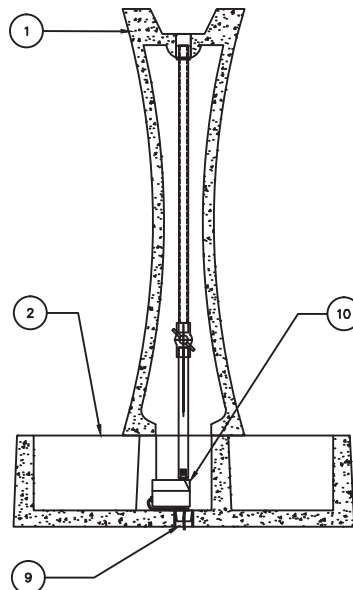

4 SECTION
SCALE: 3/4"=1'

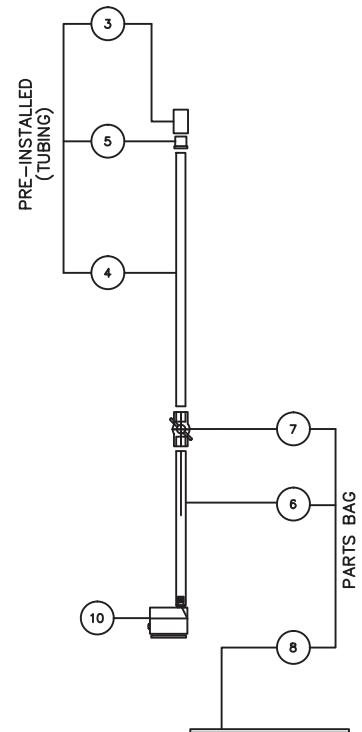

5 PIPE ASSEMBLY
SCALE: 3/4"=1'



YARDART

995 Governor Dr. #103
El Dorado Hills, CA 95762

866 382-8600

info@yardart.com

NOTE:

Electrical supply must conform with local & national regulation/codes. If in doubt consult an electrician.

To ease connections hot water may be used to soften PVC tubing. Pump and plumbing details may vary.

Precautions should be taken to prevent damage from water freezing in reservoir.

I FOUNTAIN MINI

PRODUCT
MINI I

DRAWING DATE
07-18-07

DRAWING NO
IIIF - MINI

SHEET NO. 1 OF 1

COPYRIGHT 2008 GIST DECOR 2012 GIST PRODUCTS ALL RIGHTS RESERVED