

PARTS LIST


ITEM NO	COMPONENT	PART NO.	DESCRIPTION	MANUFACTURER	QTY	REMARKS
①	FOUNTAIN	—	59'-0" x 21"W x 21"L SPIRE FOUNTAIN — GFRC	TREVI	1	COLOR OPTIONAL
②		—	21"W x 21"L x 12-3/4"D BASE — GFRC	TREVI	1	COLOR OPTIONAL
③		—	18" DIA BALL — GFRC	TREVI	1	COLOR OPTIONAL
④	TUBING	—	3/4" DIA PVC COUPLER SOCKET END	—	2	PRE-INSTALLED
⑤		—	1/2" DIA x 3'-5"LG PVC PIPE PLAIN END	—	1	PRE-INSTALLED
⑥		—	1-1/4" DIA x 1-1/8"LG PVC PIPE SLEEVE PLAIN END	—	1	PRE-INSTALLED
⑦		—	3/4"x1/2" DIA PVC CONCENTRIC REDUCER SOCKET END	—	1	PRE-INSTALLED
⑧	PARTS BAG	A119	3/4"x1/2" DIA PVC CONCENTRIC REDUCER SOCKET END	—	2	
⑨		A119	1/2" DIA x 2'-0"LG CLEAR VINYL PLAIN END	—	1	
⑩		A119	1/2" DIA BALL VALVE PVC SCH. 40 150 PSI	—	1	
⑪		A119	5/8" I.D. x 10"LG TUBING — CLEAR VINYL PLAIN END	—	1	
⑫		A119	1-1/4" RUBBER PLUG	TREVI	1	
⑬		A119	SHIM PLASTIC	EZ — SHIM	7	
⑭	PUMP	—	1"x1/2" DIA ADAPTER THREADED	JEAN TECH INC.	1	
⑮		—	VA2600, 700 GPH SUBMERSIBLE PUMP	JEAN TECH INC.	1	

NOTE:

Electrical supply must conform with local & national regulation/codes. If in doubt consult an electrician.




To ease connections hot water may be used to soften PVC tubing. Pump and plumbing details may vary.

Precautions should be taken to prevent damage from water freezing in reservoir.

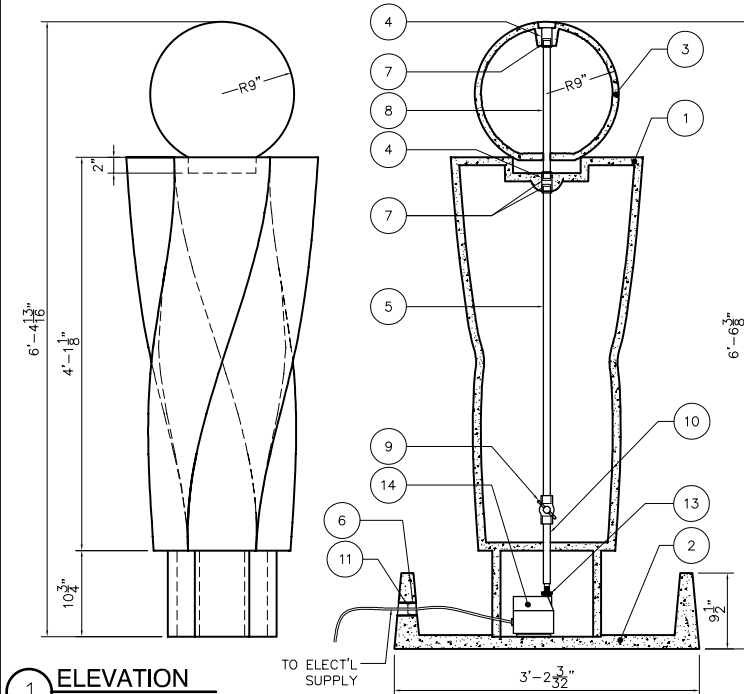

1 ELEVATION
SCALE: 1/2"=1'

2 SECTION
SCALE: 1/2"=1'

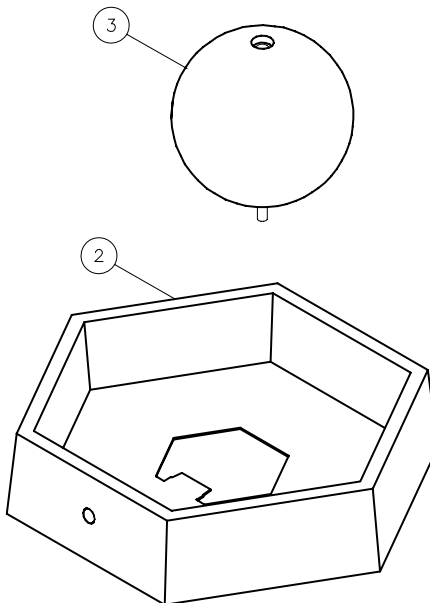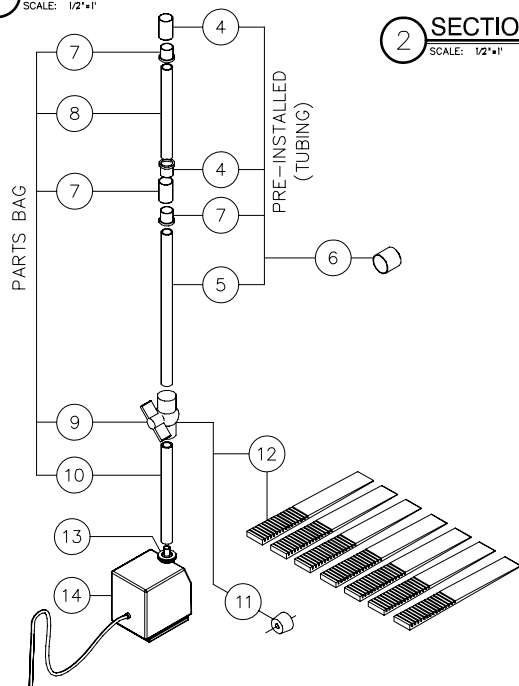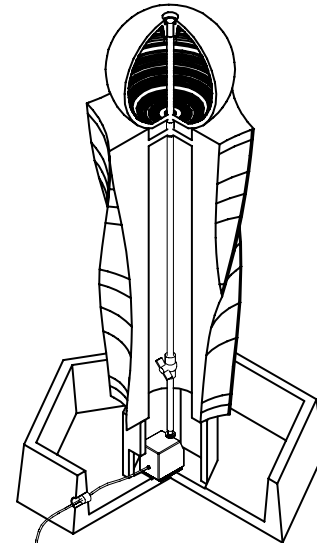

995 Governor Dr. #103
El Dorado Hills, CA 95762
866 382-8600

info@yardart.com

CONTENT
VRTX BALL
VORTEX FOUNTAIN WITH BALL

PROJECT VRTX BALL

DRAWING NO
VRTX BALL
SHOP

SHEET. NO. 1 OF 1